



H:\VCOM\Building Plans\Other Campus\Carolinas\Dupre House - Fire Evacuation Plan.dwg Dec 04, 2024 - 10:40am

LEGEND

-  - Fire Emergency Exit Route
-  - Severe Weather Shelter Area

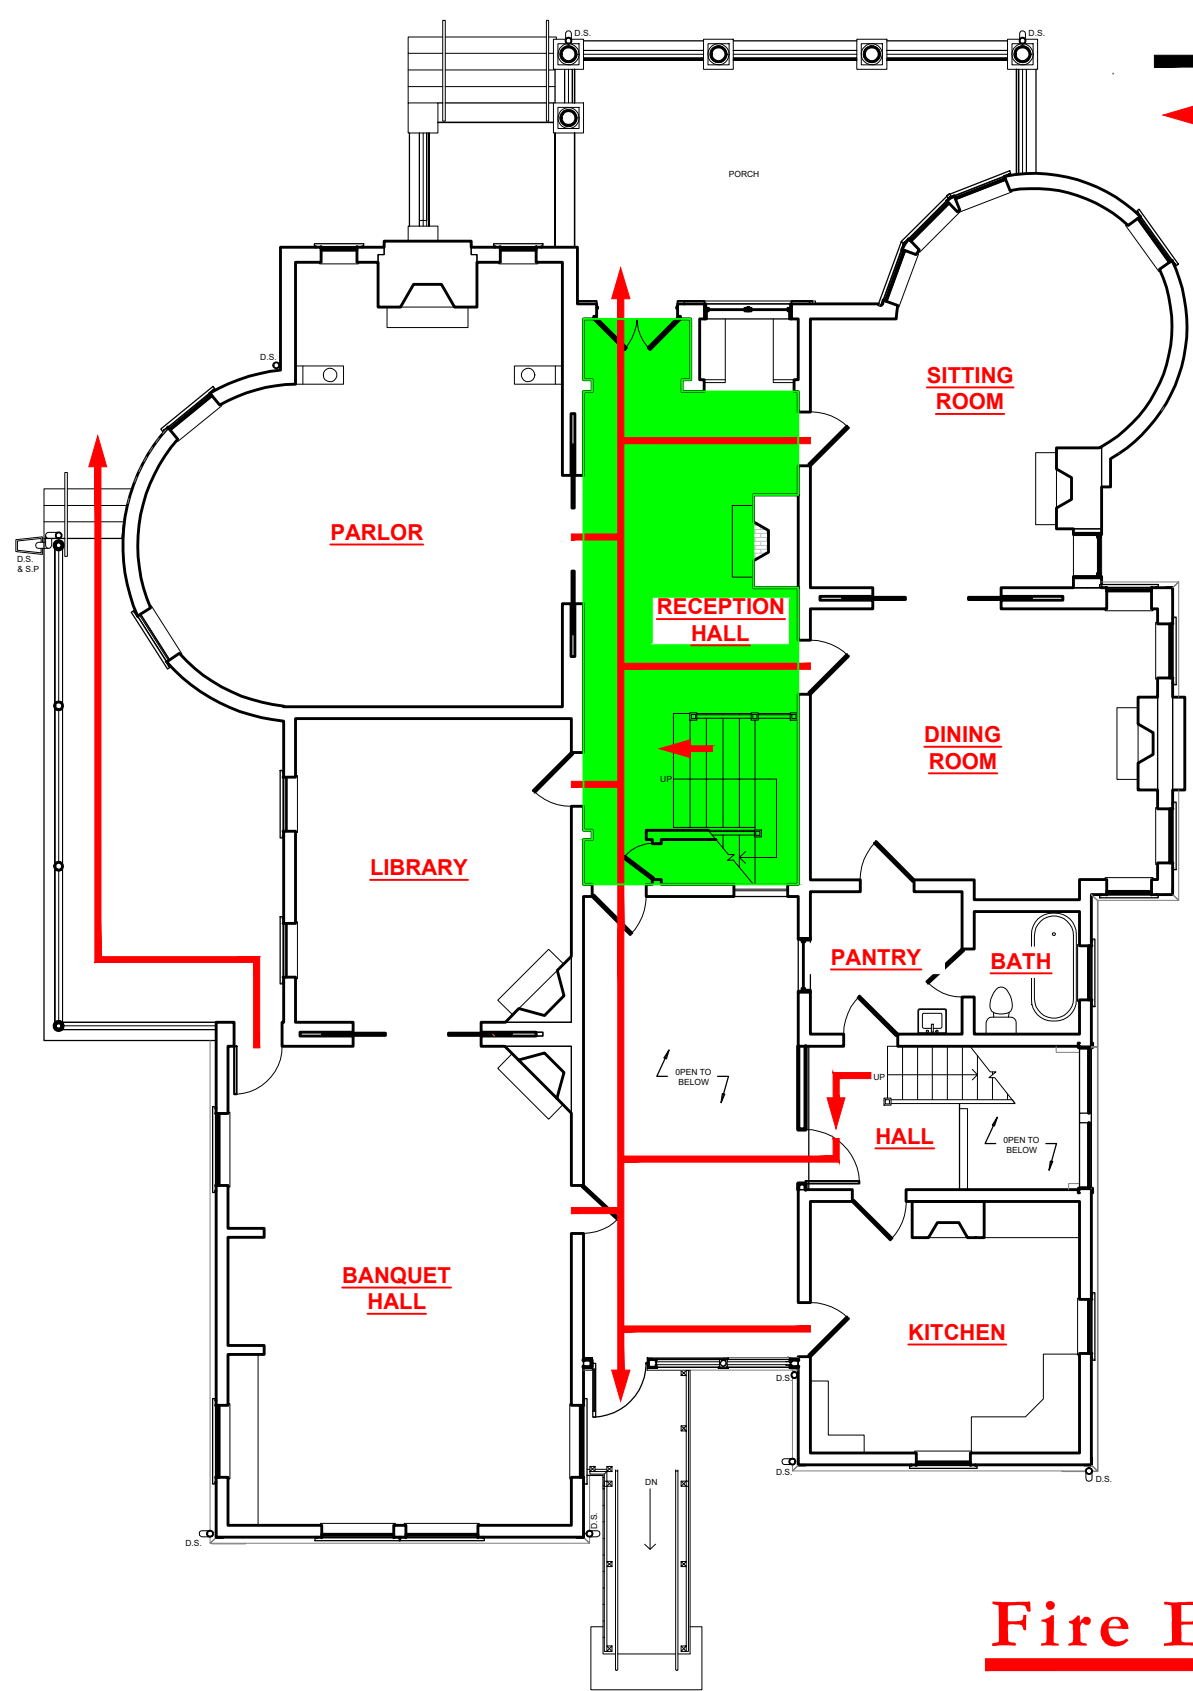


FIRST FLOOR PLAN

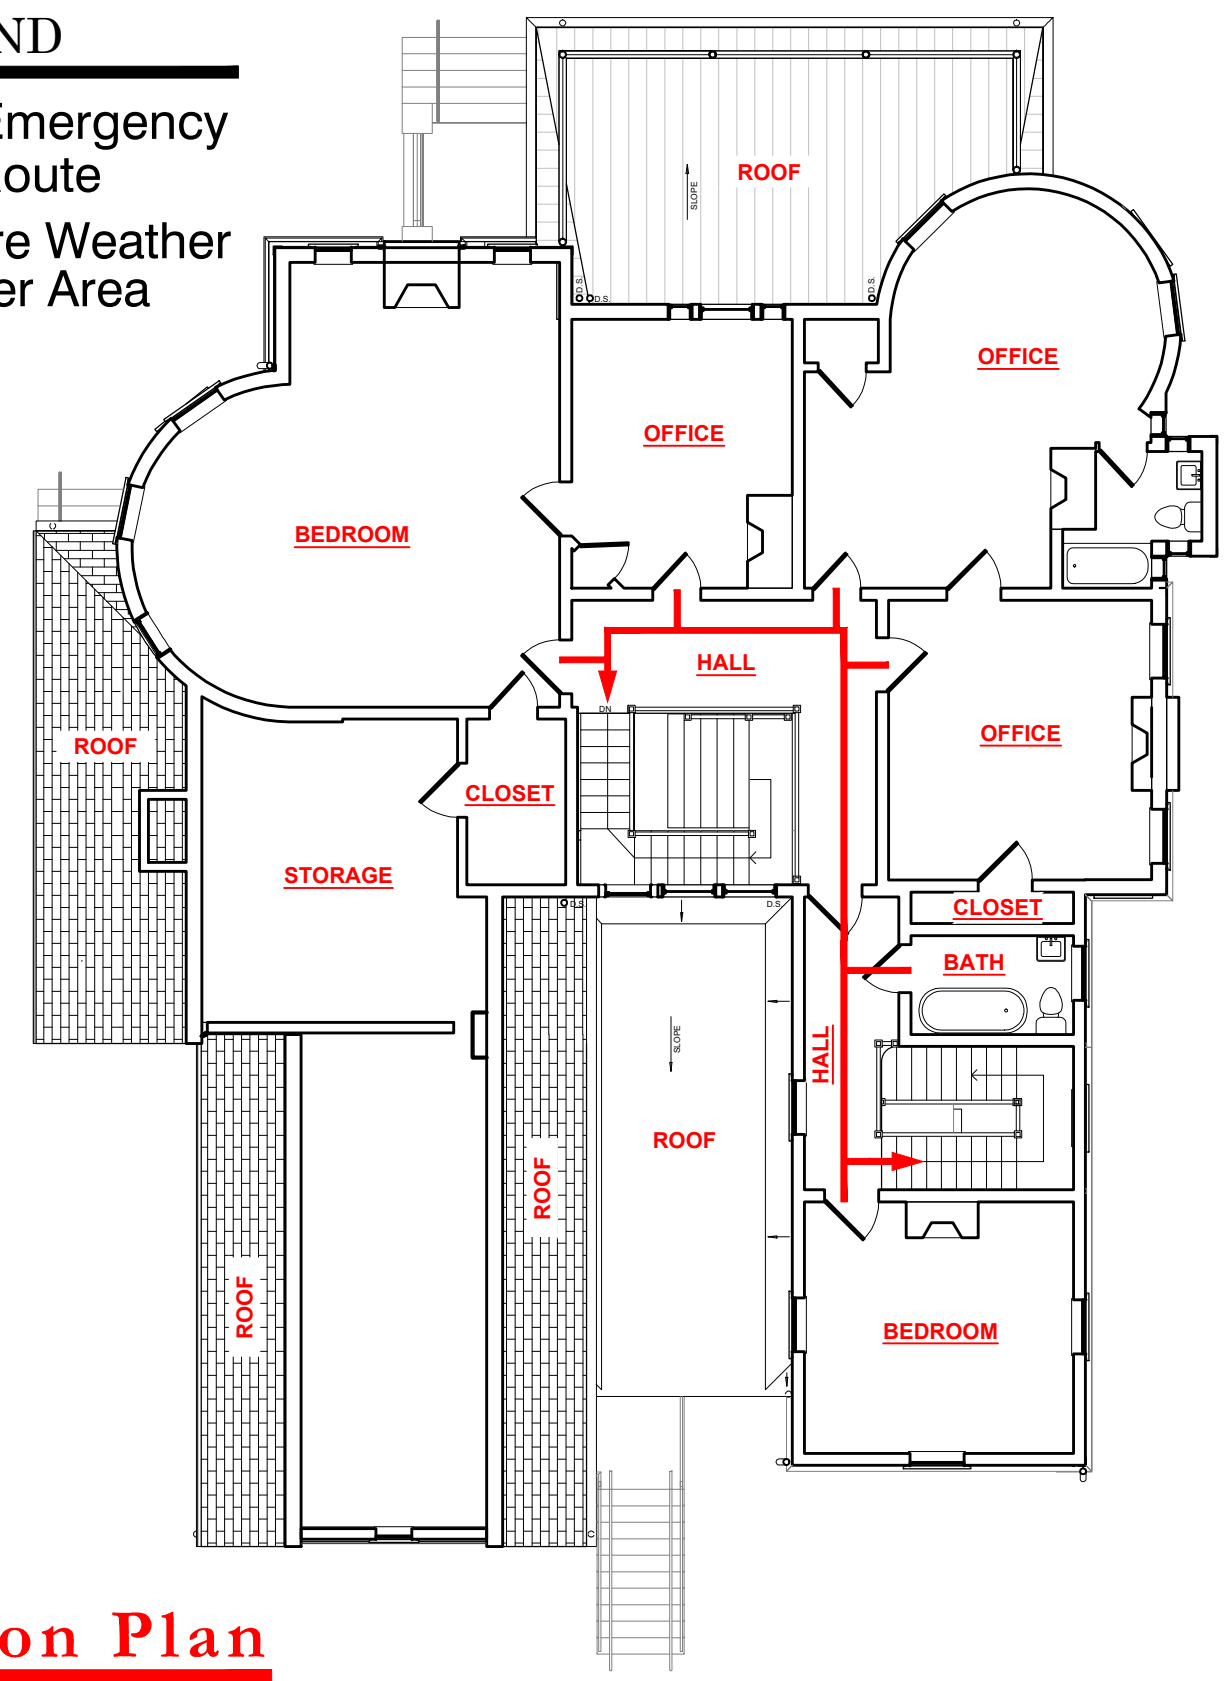

SECOND FLOOR PLAN

 Fire Evacuation Plan



VCOM Carolinas Campus - Dupre House - Spartanburg - South Carolina

Scale: NTS

